
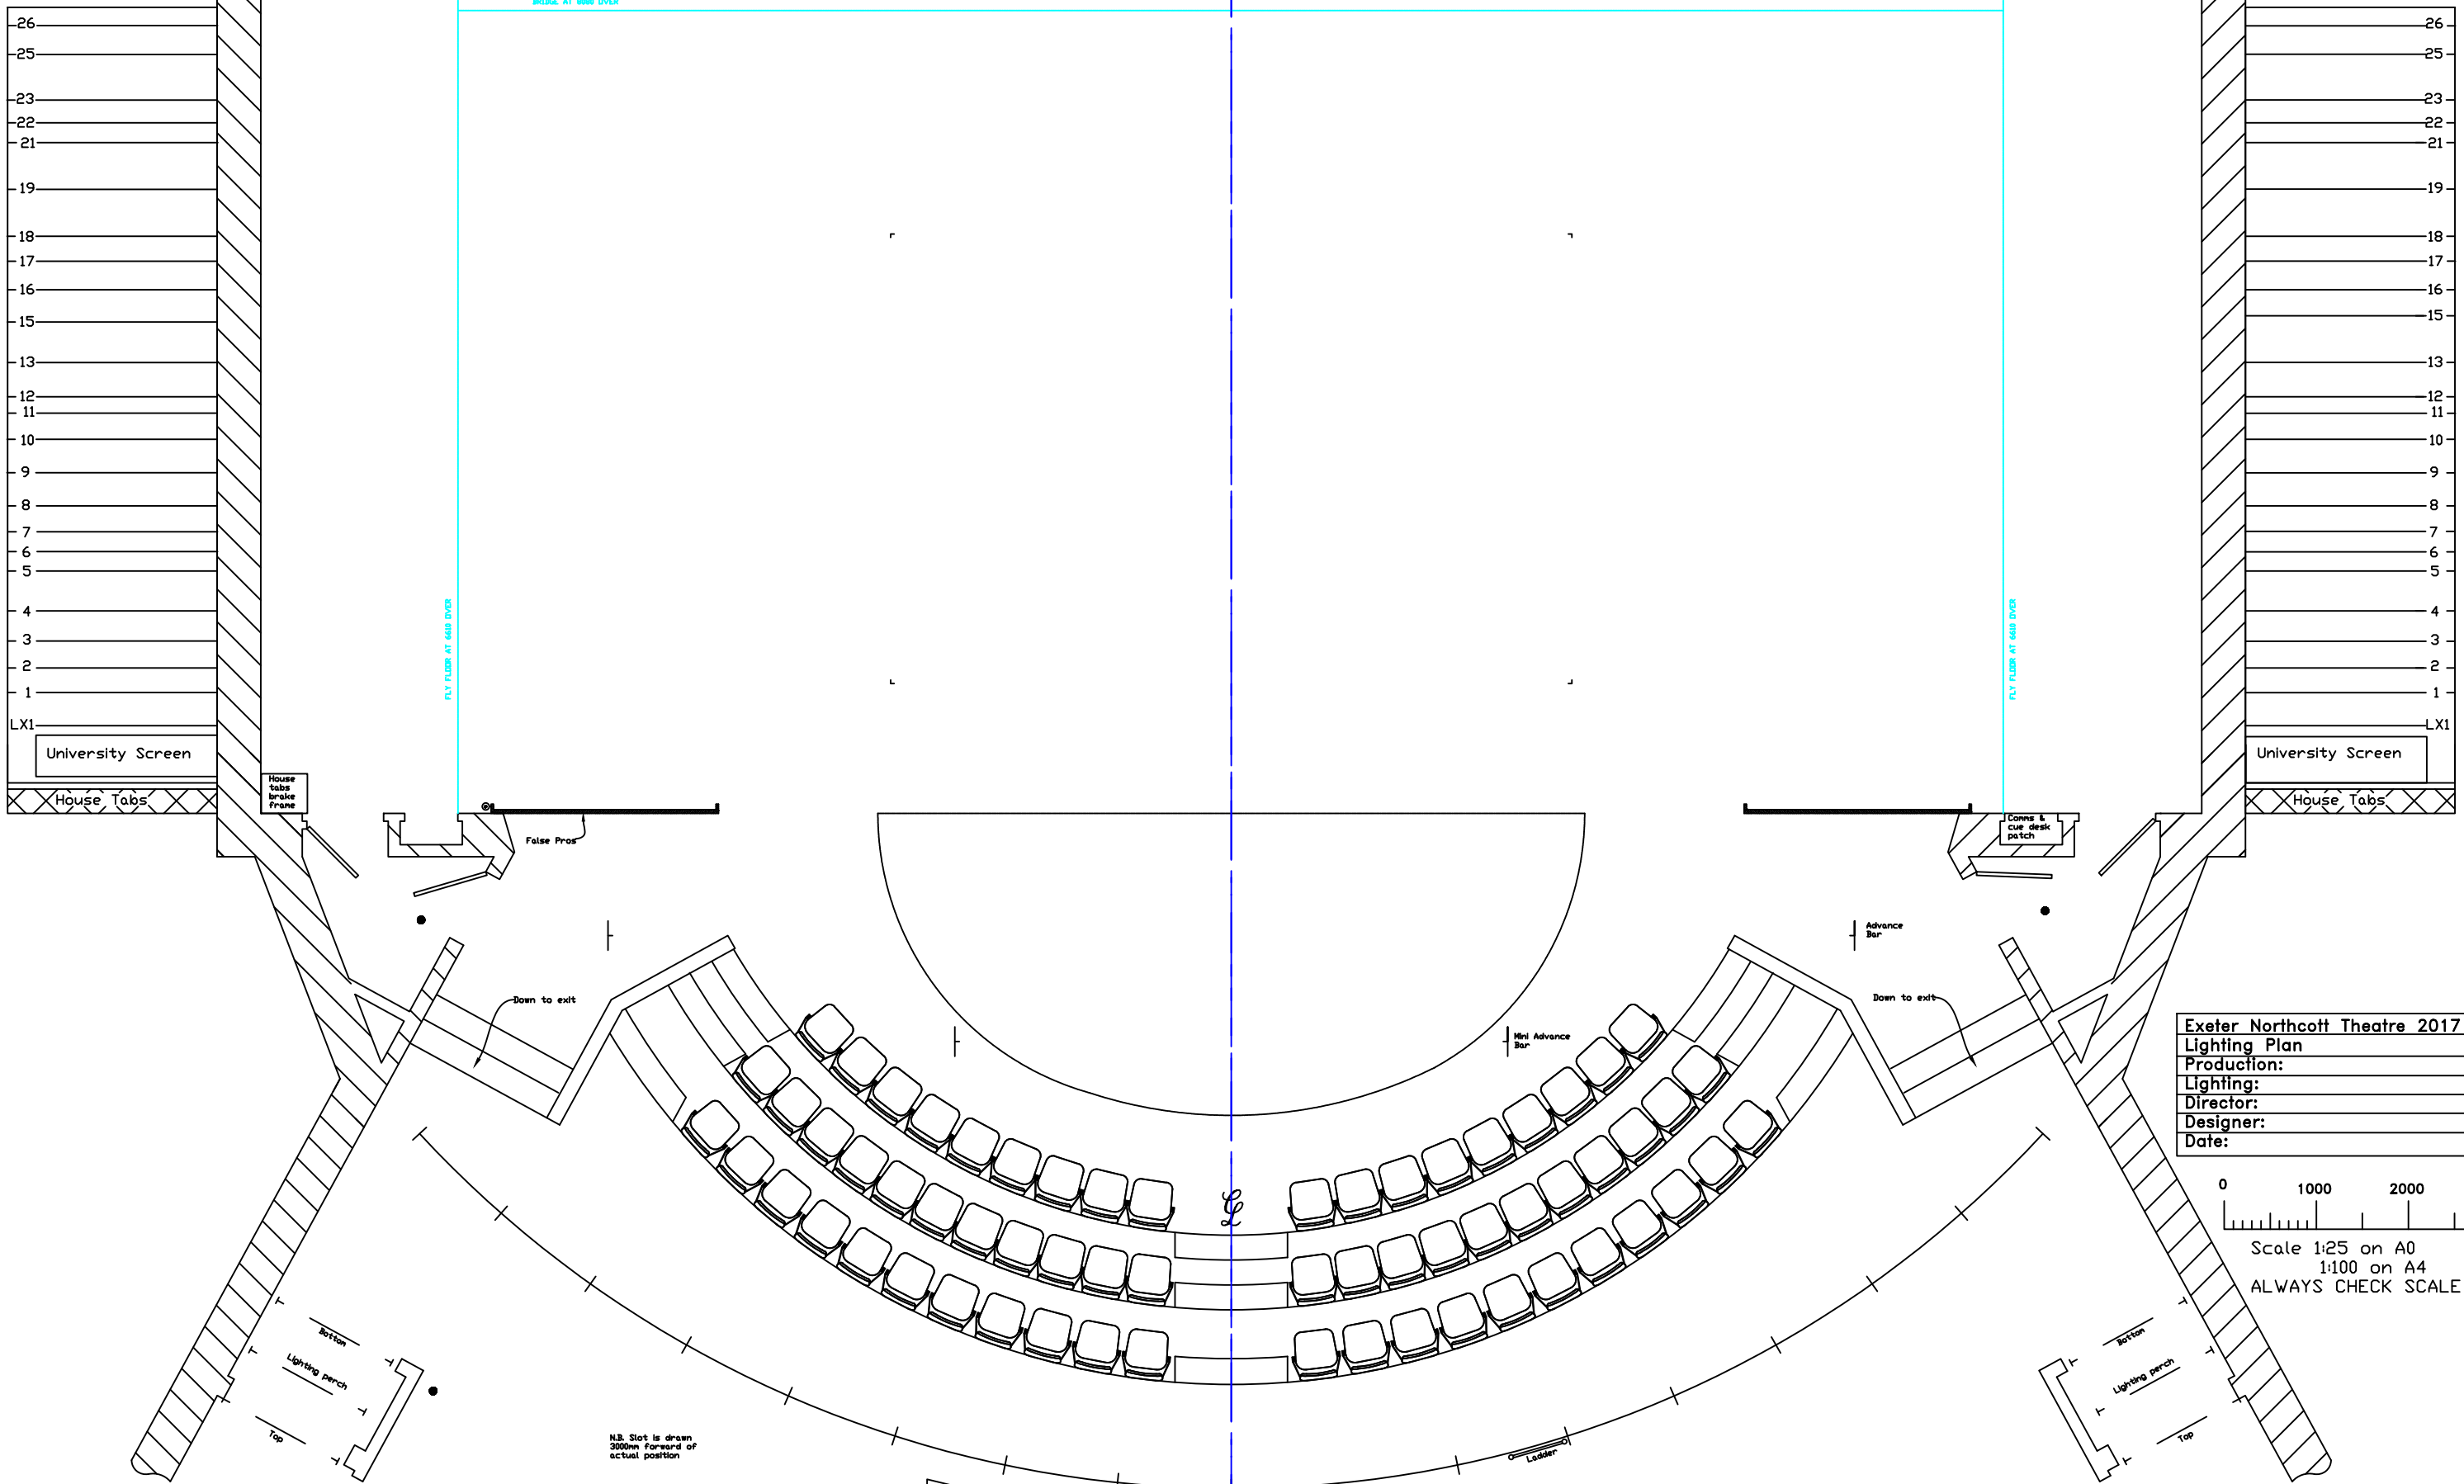
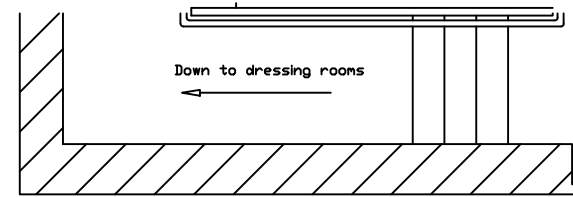



Double Purchase Counterweight system operated from this side  
 Blocks on grid are often moved to get things to pass - positions are correct as of 21.01.2012

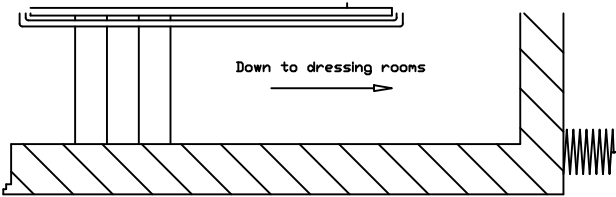

- 26
- 25
- 23
- 22
- 21
- 19
- 18
- 17
- 16
- 15
- 13
- 12
- 11
- 10
- 9
- 8
- 7
- 6
- 5
- 4
- 3
- 2
- 1
- LX1

- 26
- 25
- 23
- 22
- 21
- 19
- 18
- 17
- 16
- 15
- 13
- 12
- 11
- 10
- 9
- 8
- 7
- 6
- 5
- 4
- 3
- 2
- 1
- LX1

 Exeter Northcott Theatre 2017
Lighting Plan
Production:
Lighting:
Director:
Designer:
Date:



Scale 1:25 on A0  
 1:100 on A4  
 ALWAYS CHECK SCALE BAR

N.B. Slot is drawn 3000mm forward of actual position